


Legends:

Gross Internal Areas  
 Imperial Suite  
 Total - 851 m<sup>2</sup> (9160 ft<sup>2</sup>)

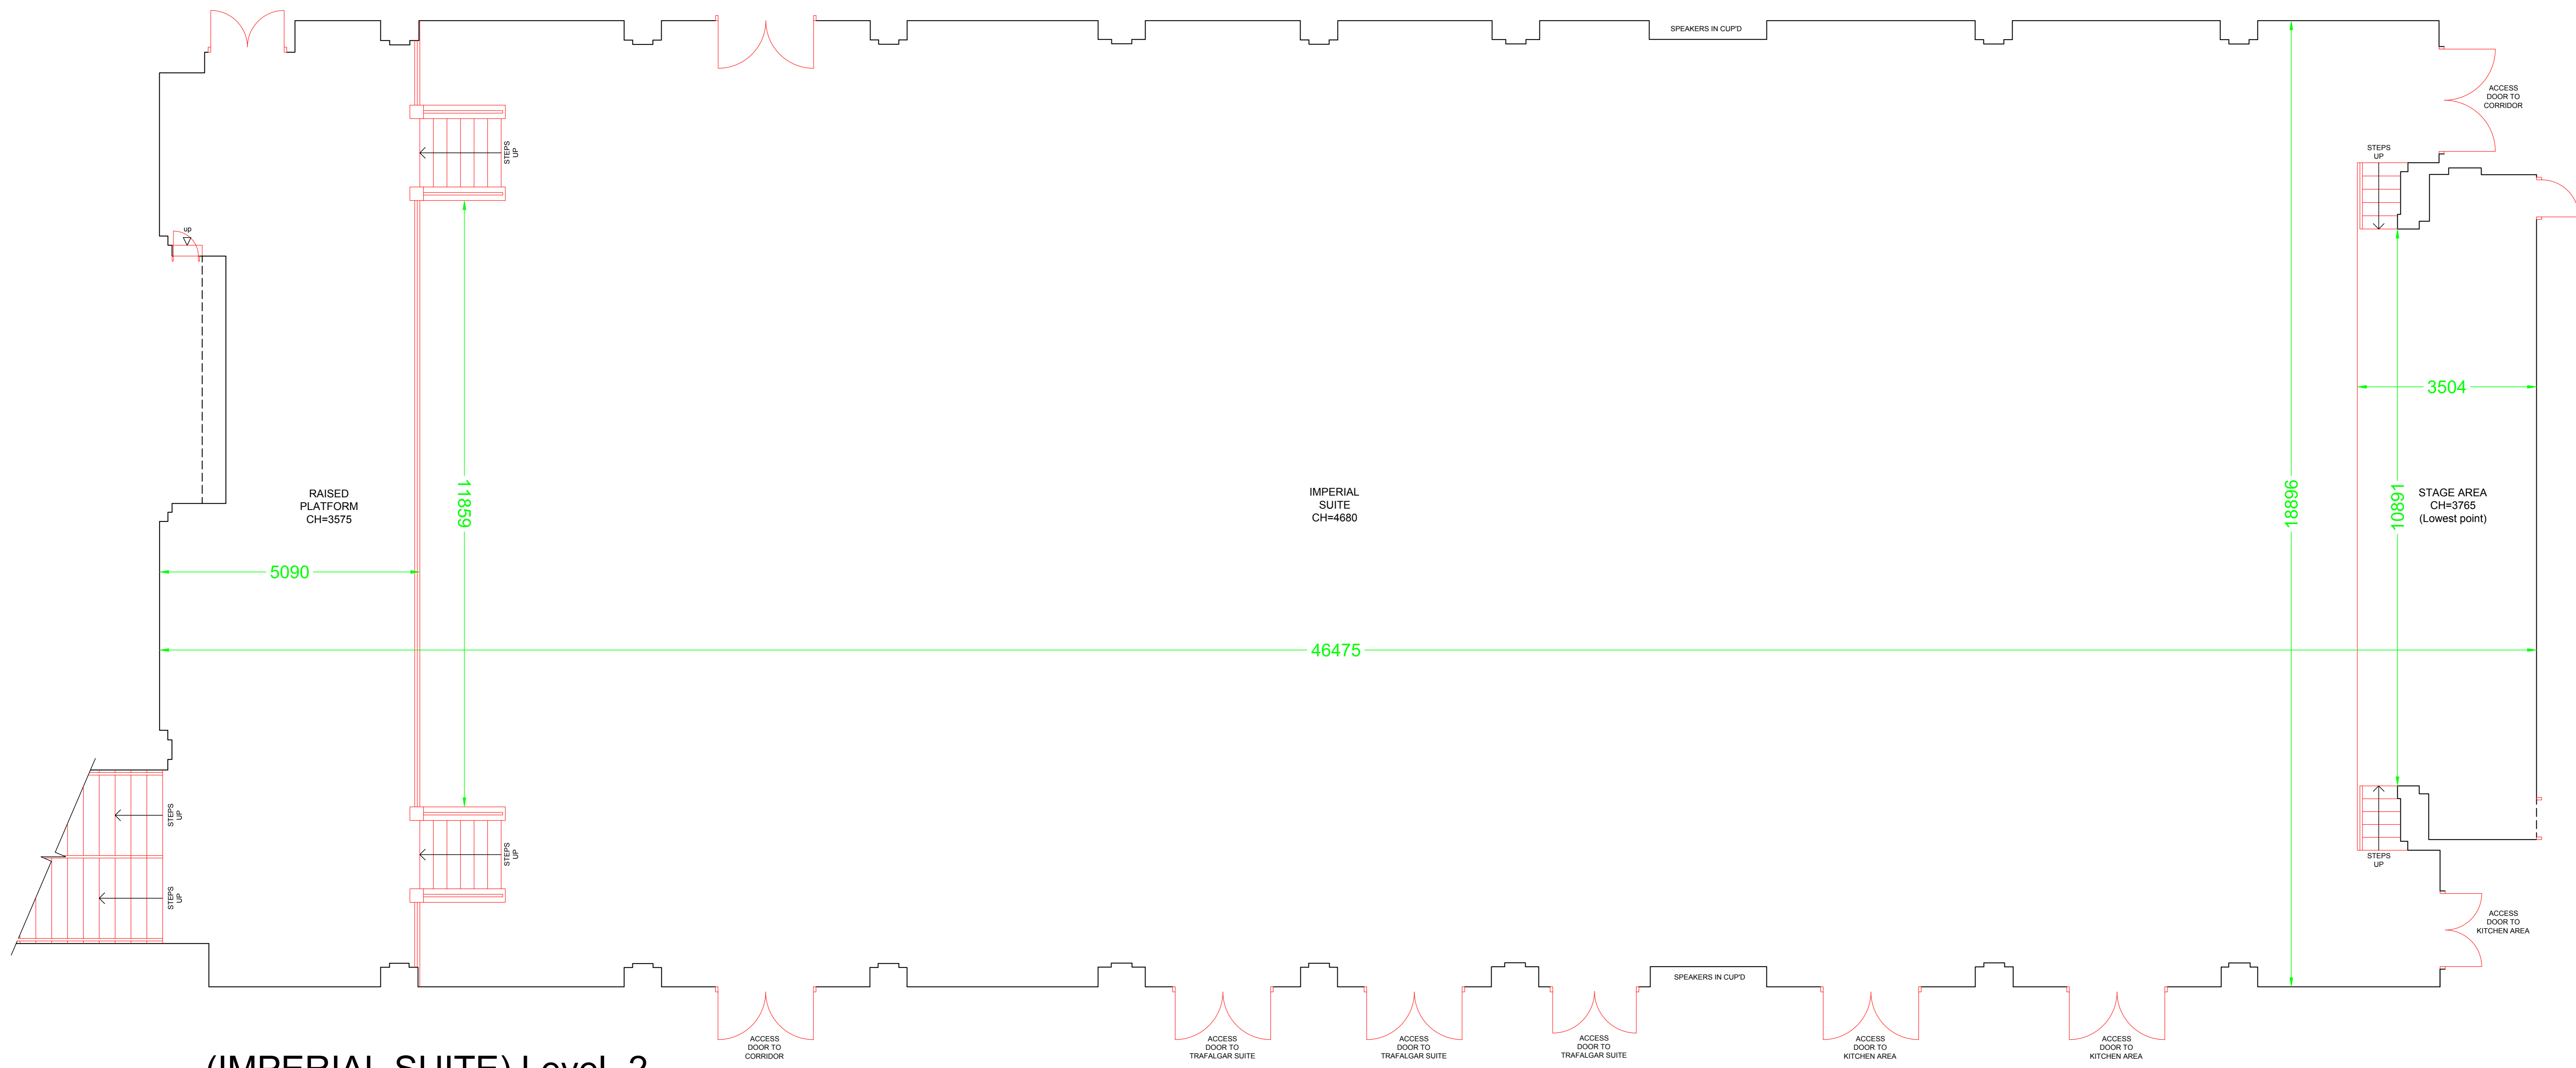

(IMPERIAL SUITE) Level -2

SYMBOLS LEGEND

[Symbol]	ROLLER SHUTTERS UP/DOWN SWITCH
[Symbol]	SINGLE LIGHT SWITCH
[Symbol]	DOUBLE LIGHT SWITCH
[Symbol]	DIMMER LIGHT SWITCH
[Symbol]	DIMMER CONTROL PANEL
[Symbol]	BLANK PLATE
[Symbol]	DOUBLE SOCKET
[Symbol]	SINGLE SOCKET
[Symbol]	WALL MOUNTED DAX SOCKET
[Symbol]	WALL MOUNTED MICROPHONE SOCKET
[Symbol]	3 PHASE ISOLATOR PLUG SOCKET
[Symbol]	4 Pin (x15pin) SOCKET
[Symbol]	Single Data Socket
[Symbol]	DOUBLE DATA SOCKET
[Symbol]	ROOM TEMPERATURE CONTROL/DISPLAY
[Symbol]	FIRE EXIT SIGN
[Symbol]	FIRE BREAK GLASS POINT
[Symbol]	FIRE EXTINGUISHER (WATER)
[Symbol]	FIRE EXTINGUISHER (CARBON DIOXIDE)
[Symbol]	FIRE EXTINGUISHER (FOAM)
[Symbol]	FIRE EXTINGUISHER (POWDER)

Level Data	Fence Types
Level	Level
Traps	Traps
...	...

REV	DATE	BY	DESCRIPTION

**CADS**  
 A Design Services Limited  
 The Design Centre, Newell Road, Gosport, Hants,  
 PO15 5JF, UK  
 Tel: 01483 48844 www.cadsdesignservices.co.uk  
 Registered in England No. 1595687

CLIENT  
**NATIONAL CONFERENCE CENTRE**  
 SITE ADDRESS  
 COVENTRY ROAD,  
 BICKENHILL,  
 SOLIHULL,  
 B92 0EJ

TITLE  
**IMPERIAL SUITE  
 EXISTING FLOOR PLAN**

DRAWN BY	DATE	SCALE	SHEET NO	TOTAL SHEETS
LS	JUNE 2016	1:500/AS	AG	AG
DESIGNED BY	DATE	APPROVED BY	DATE	
LSIT	JUNE 2016	CAD	JUNE 2016	

DRAWING NO: **31799 IMPERIAL** REVISION: **0**