


Legends:

Gross Internal Areas
Compton Suite
Total - 359m² (3864 ft²)

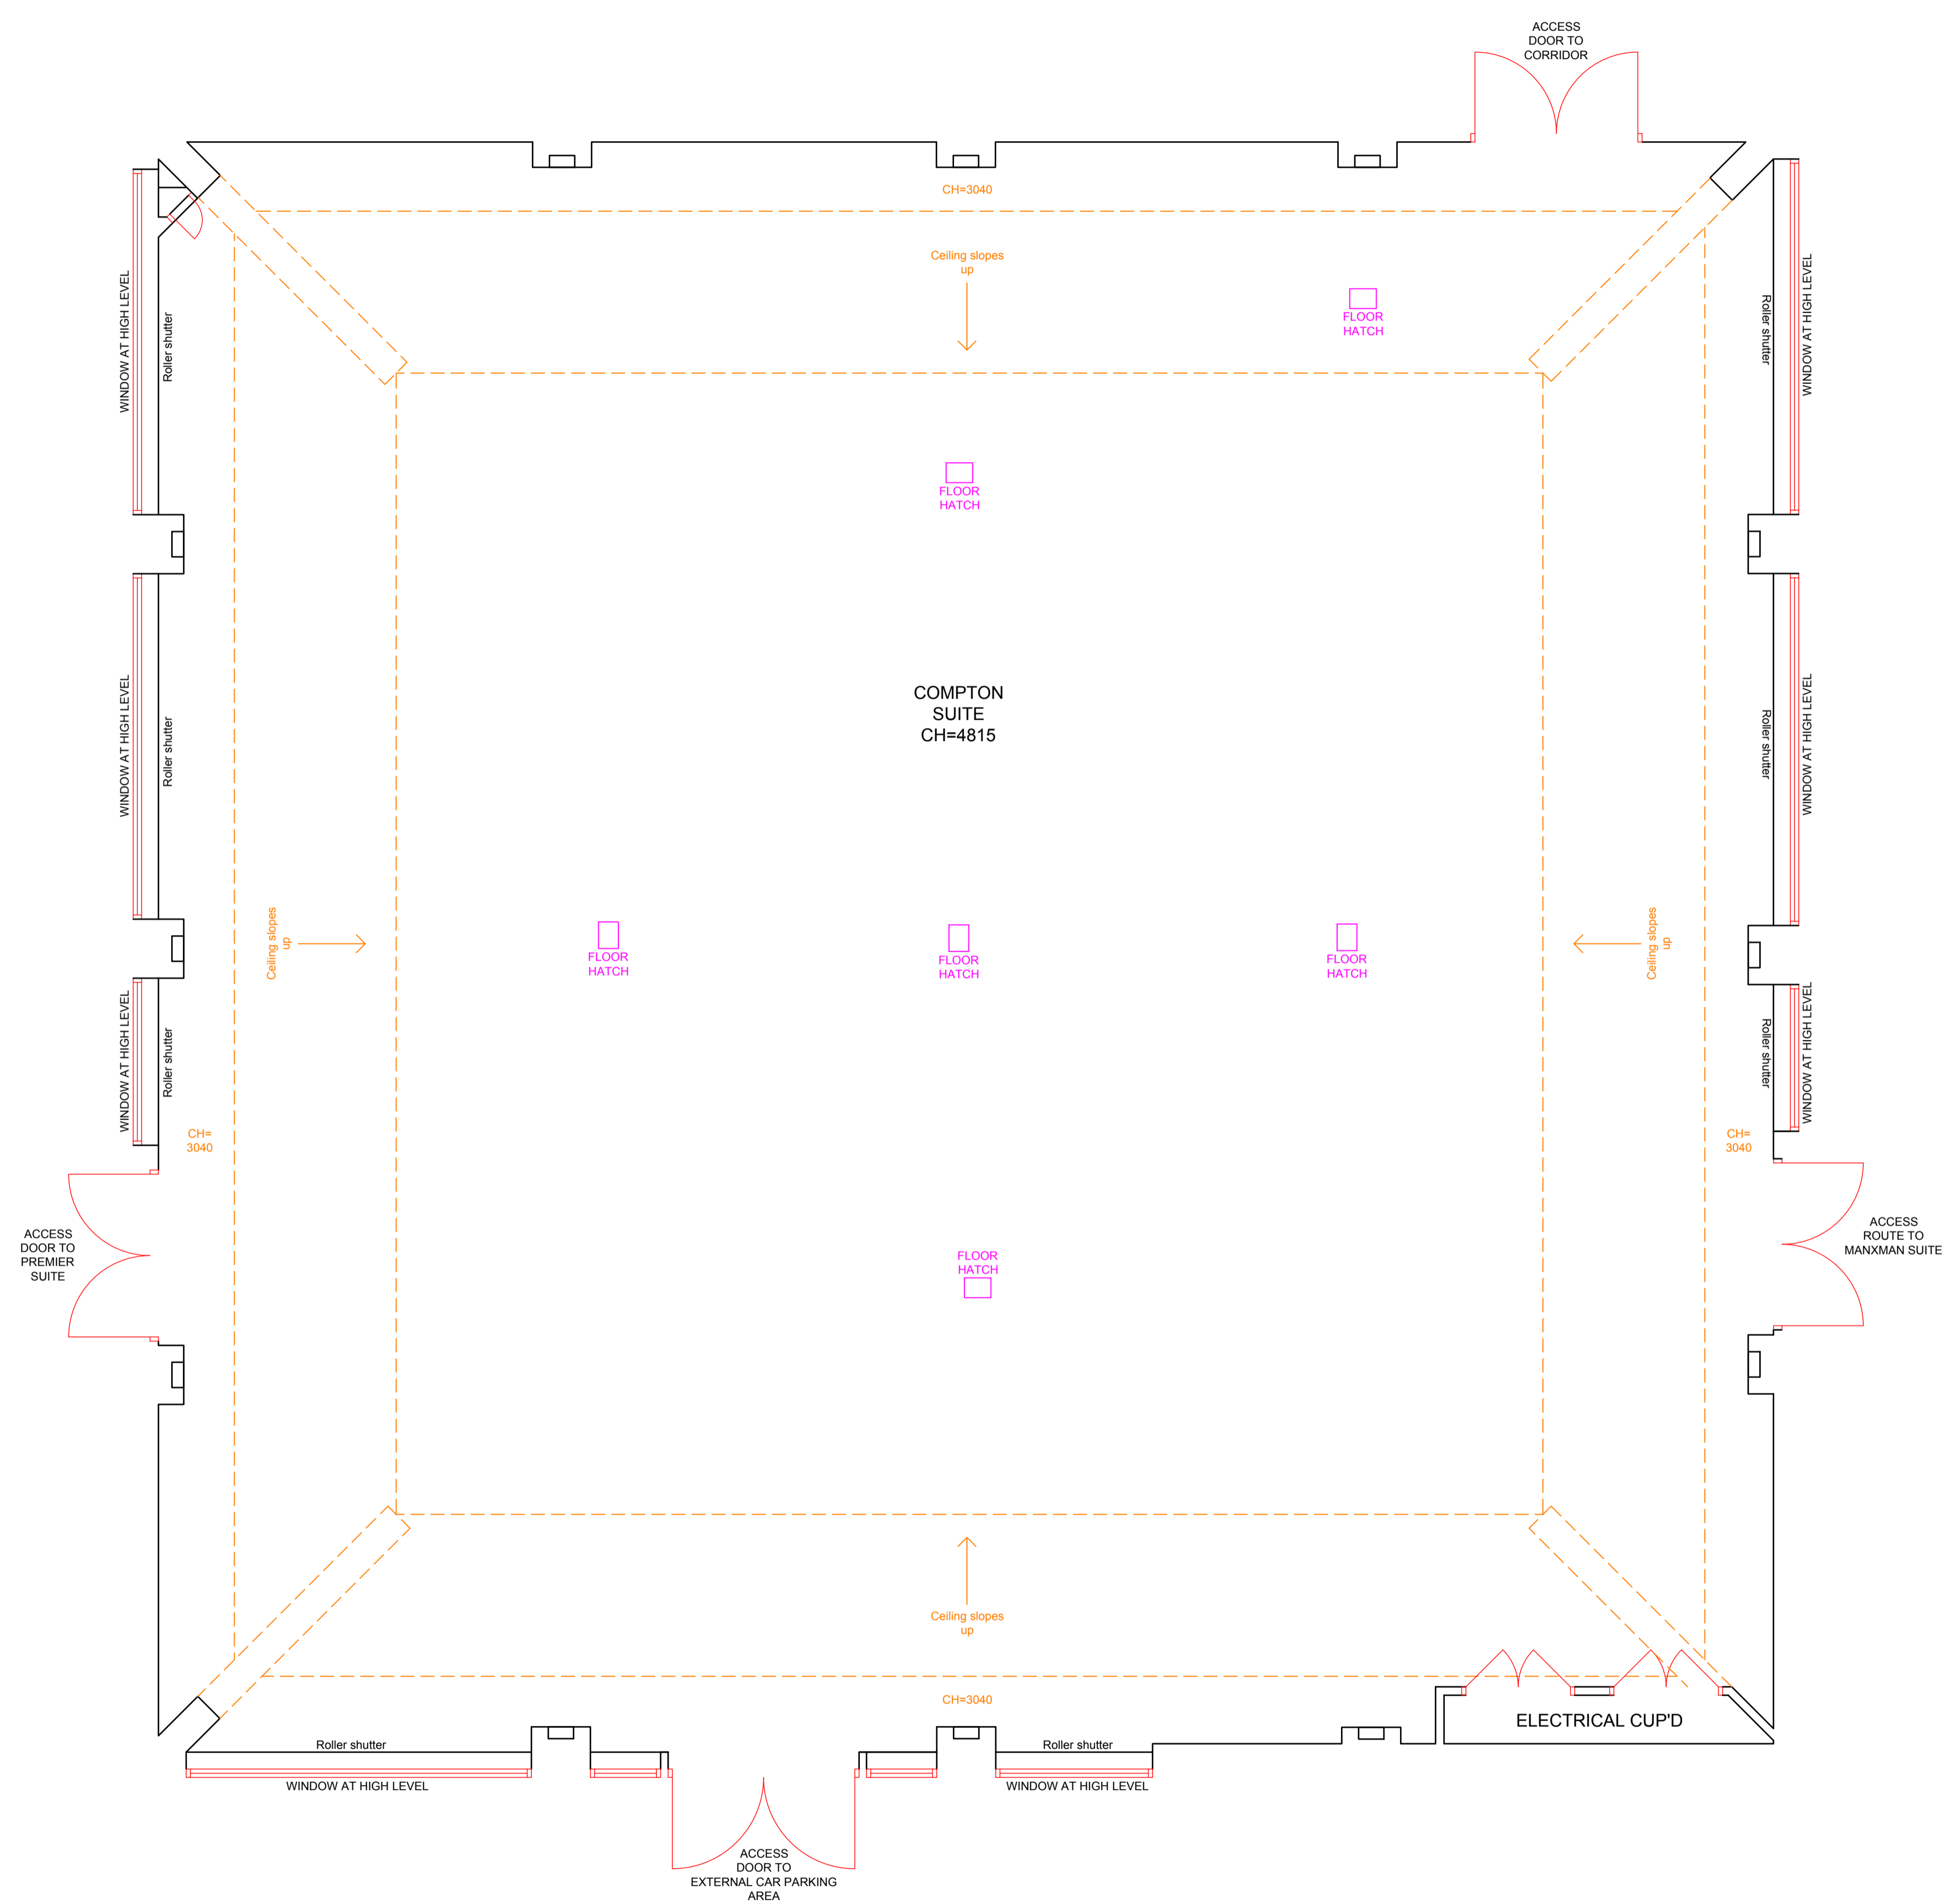

(COMPTON SUITE) Ground floor

SYMBOLS LEGEND

	ROLLER SHUTTERS UP/DOWN SWITCH
	SINGLE LIGHT SWITCH
	DOUBLE LIGHT SWITCH
	DIMMER LIGHT SWITCH
	DIMMER CONTROL PANEL
	BLANK PLATE
	SINGLE SOCKET
	DOUBLE SOCKET
	WALL MOUNTED DMX SOCKET
	WALL MOUNTED MICROPHONE SOCKET
	3 PHASE ISOLATOR PLUG SOCKET
	5amp (x10pin) SOCKET
	SINGLE DATA SOCKET
	DOUBLE DATA SOCKET
	ROOM TEMPERATURE CONTROL/DISPLAY
	FIRE EXIT SIGN
	FIRE BREAK GLASS POINT
	FIRE EXTINGUISHER (WATER)
	FIRE EXTINGUISHER (CARBON DIOXIDE)
	FIRE EXTINGUISHER (FOAM)
	FIRE EXTINGUISHER (POWDER)

Level Data		Fence Types	
Spot Levels	+ 99.75	BW	Buried Wire
Trees	These Are Drawn To Scale On The Survey. Descriptions Should Only Be Used As A Guide	CB	Chain Beamed
Tree Type	Height	CC	Composite Iron
UK	Unknown Tree Type	CL	Chain Link
		CP	Chastnut Paving
		IR	Iron Slating
		PA	Panel Fence
		FB	Flint & Rail
		PW	Flint & Wire

Abbreviations		Fence Types	
ACU	Air Conditioner Unit	MH	Maximum Internal Height
BA	Banner	OH	Overhead Height
BB	Beltline	PS	Post Sign
BS	Beltline Beacon	PR	Painting Meter
BS	Belt Sign	PO	Post
BU	Bulk	PO	Post
CA	Cable TV	RE	Rodding Eye
CA TV	Cable TV Cover	RE	Rodding Eye
CH	Ceiling Height	RF	Raised Floor Void
CHC	Ceiling Height Change	RS	Road Sign
CH	Clear Internal Height	RSP	Road Sign
CL	Clear Level	S	Sign
CPB	Concrete Paving Slabs	SC	Strip Sign
CSU	Ceiling Slopes Up	SCH	Supporting Ceiling Height
DH	Door Height	SI	Sign Post
DIP	Down Pipe	STN	Station
DR	Drain	SV	Sign Valve
EH	Earth Height	SV	Sign Valve
ER	Earth Root	TAC	Trunk Access Cover
FD	Floor Duct	TC	Trunk Cover
FFL	Finished Floor Level	TB	Telephone Box
FL	Floor Level	TL	Traffic Light
PH	Fire Hydrant	TL	Telephone Pole
QG	Quick Grab	UC	Underground Cover
H	Height	UNS	Understand
IC	Inspection Chamber	UNSL	Understand CP Beam
LP	Lamp Post	UTL	Unstable To Lift
MH	Manhole	VP	Vertical Pole
		WCH	Window Over Height

REV.	DATE	BY	DESCRIPTION

CADS
Surveys
 C A Design Services Limited
 The Design Centre, Hewett Road, Gapton Hall,
 Great Yarmouth, Norfolk, NR31 0NN
 Tel: 01493 440444 www.cadsdesignservices.co.uk
 Registered in England No. 1595687

CLIENT
NATIONAL CONFERENCE CENTRE

SITE ADDRESS
**COVENTRY ROAD,
 BICKENHILL,
 SOLIHULL,
 B92 0EJ**

TITLE
**COMPTON SUITE
 EXISTING FLOOR PLAN**

DRAWN BY	DATE	SCALE	SHEET SIZE
LS	JUNE 2016	1/50@A1	A1
CHECKED BY	DATE	APPROVED BY	DATE
LSIT	JUNE 2016	CADS	JUNE 2016
DRAWING No.	31799_COMPTON		REVISION
			0