

Legends:

Gross Internal Areas

Compton Suite
Total - 359m² (3864 ft²)


SYMBOLS LEGEND

	ROLLER SHUTTERS UP/DOWN SWITCH
	SINGLE LIGHT SWITCH
	DOUBLE LIGHT SWITCH
	DIMMER LIGHT SWITCH
	DIMMER CONTROL PANEL
	BLANK PLATE
	SINGLE SOCKET
	DOUBLE SOCKET
	WALL MOUNTED DMX SOCKET
	WALL MOUNTED MICROPHONE SOCKET
	3 PHASE ISOLATOR PLUG SOCKET
	5amp (x10pin) SOCKET
	SINGLE DATA SOCKET
	DOUBLE DATA SOCKET
	ROOM TEMPERATURE CONTROL/DISPLAY
	FIRE EXIT SIGN
	FIRE BREAK GLASS POINT
	FIRE EXTINGUISHER (WATER)
	FIRE EXTINGUISHER (CARBON DIOXIDE)
	FIRE EXTINGUISHER (FOAM)
	FIRE EXTINGUISHER (POWDER)

Level Data	
Spot Levels	+ 100 TS

Fence Types	
BSI	British Standard
CB	Close Boarded
CL	Chain Link
CO	Cornelium Mesh
CR	Cricket Netting
IR	Iron Railing
PR	Painted Fence
FR	Fence & Rail
PR	Post & Rail
PR	Post & Wire

Abbreviations	
AQJ	Air Conditioner Unit
BA	Baluster
BS	British Standard
BO	Bobbed
BS	Brick Slip
BU	Bush
CATV	Cable TV Cover
CH	Ceiling Height
CHC	Ceiling Height Change
CH	Clear Internal Height
CL	Cover Level
CPS	Concrete Paving Slabs
CSLJ	Ceiling Slab Joist
DR	Door Height
DP	Down Pipe
DH	Down Pipe
DS	Down
EH	Eaves Height
ER	Earth Rod
FD	Floor Slab
FFL	Finished Floor Level
FL	Floor Level
FR	Fire Hydrant
GS	Gully Cover
H	Height
IC	Inspection Chamber
LPR	Lamp Post
MAN	Mansard
MSH	Maximum Internal Height
OH	Opening Height
PH	Post Hole
PM	Painting Meter
PD	Post
RA	Rail
RE	Rendition Eye
RFV	Roof Floor Void
RS	Roof Slab
RWP	Rainwater Pipe
S	Sill
SC	Stop Cock
SCH	Suspended Ceiling Height
SI	Sign Post
SK	Skirting
SP	Stop Valve
SPAP	Spot Vent Pipe
TAC	Task Access Cover
TC	Telephone Cover
TR	Telephone Box
TL	Traffic Light
TR	Trough Pipe
ULC	Underpass Cover
URS	Underpass
URS	Underpass Of Beam
UFL	Underpass To Lift
VP	Vent Pipe
WCH	Window Over Height

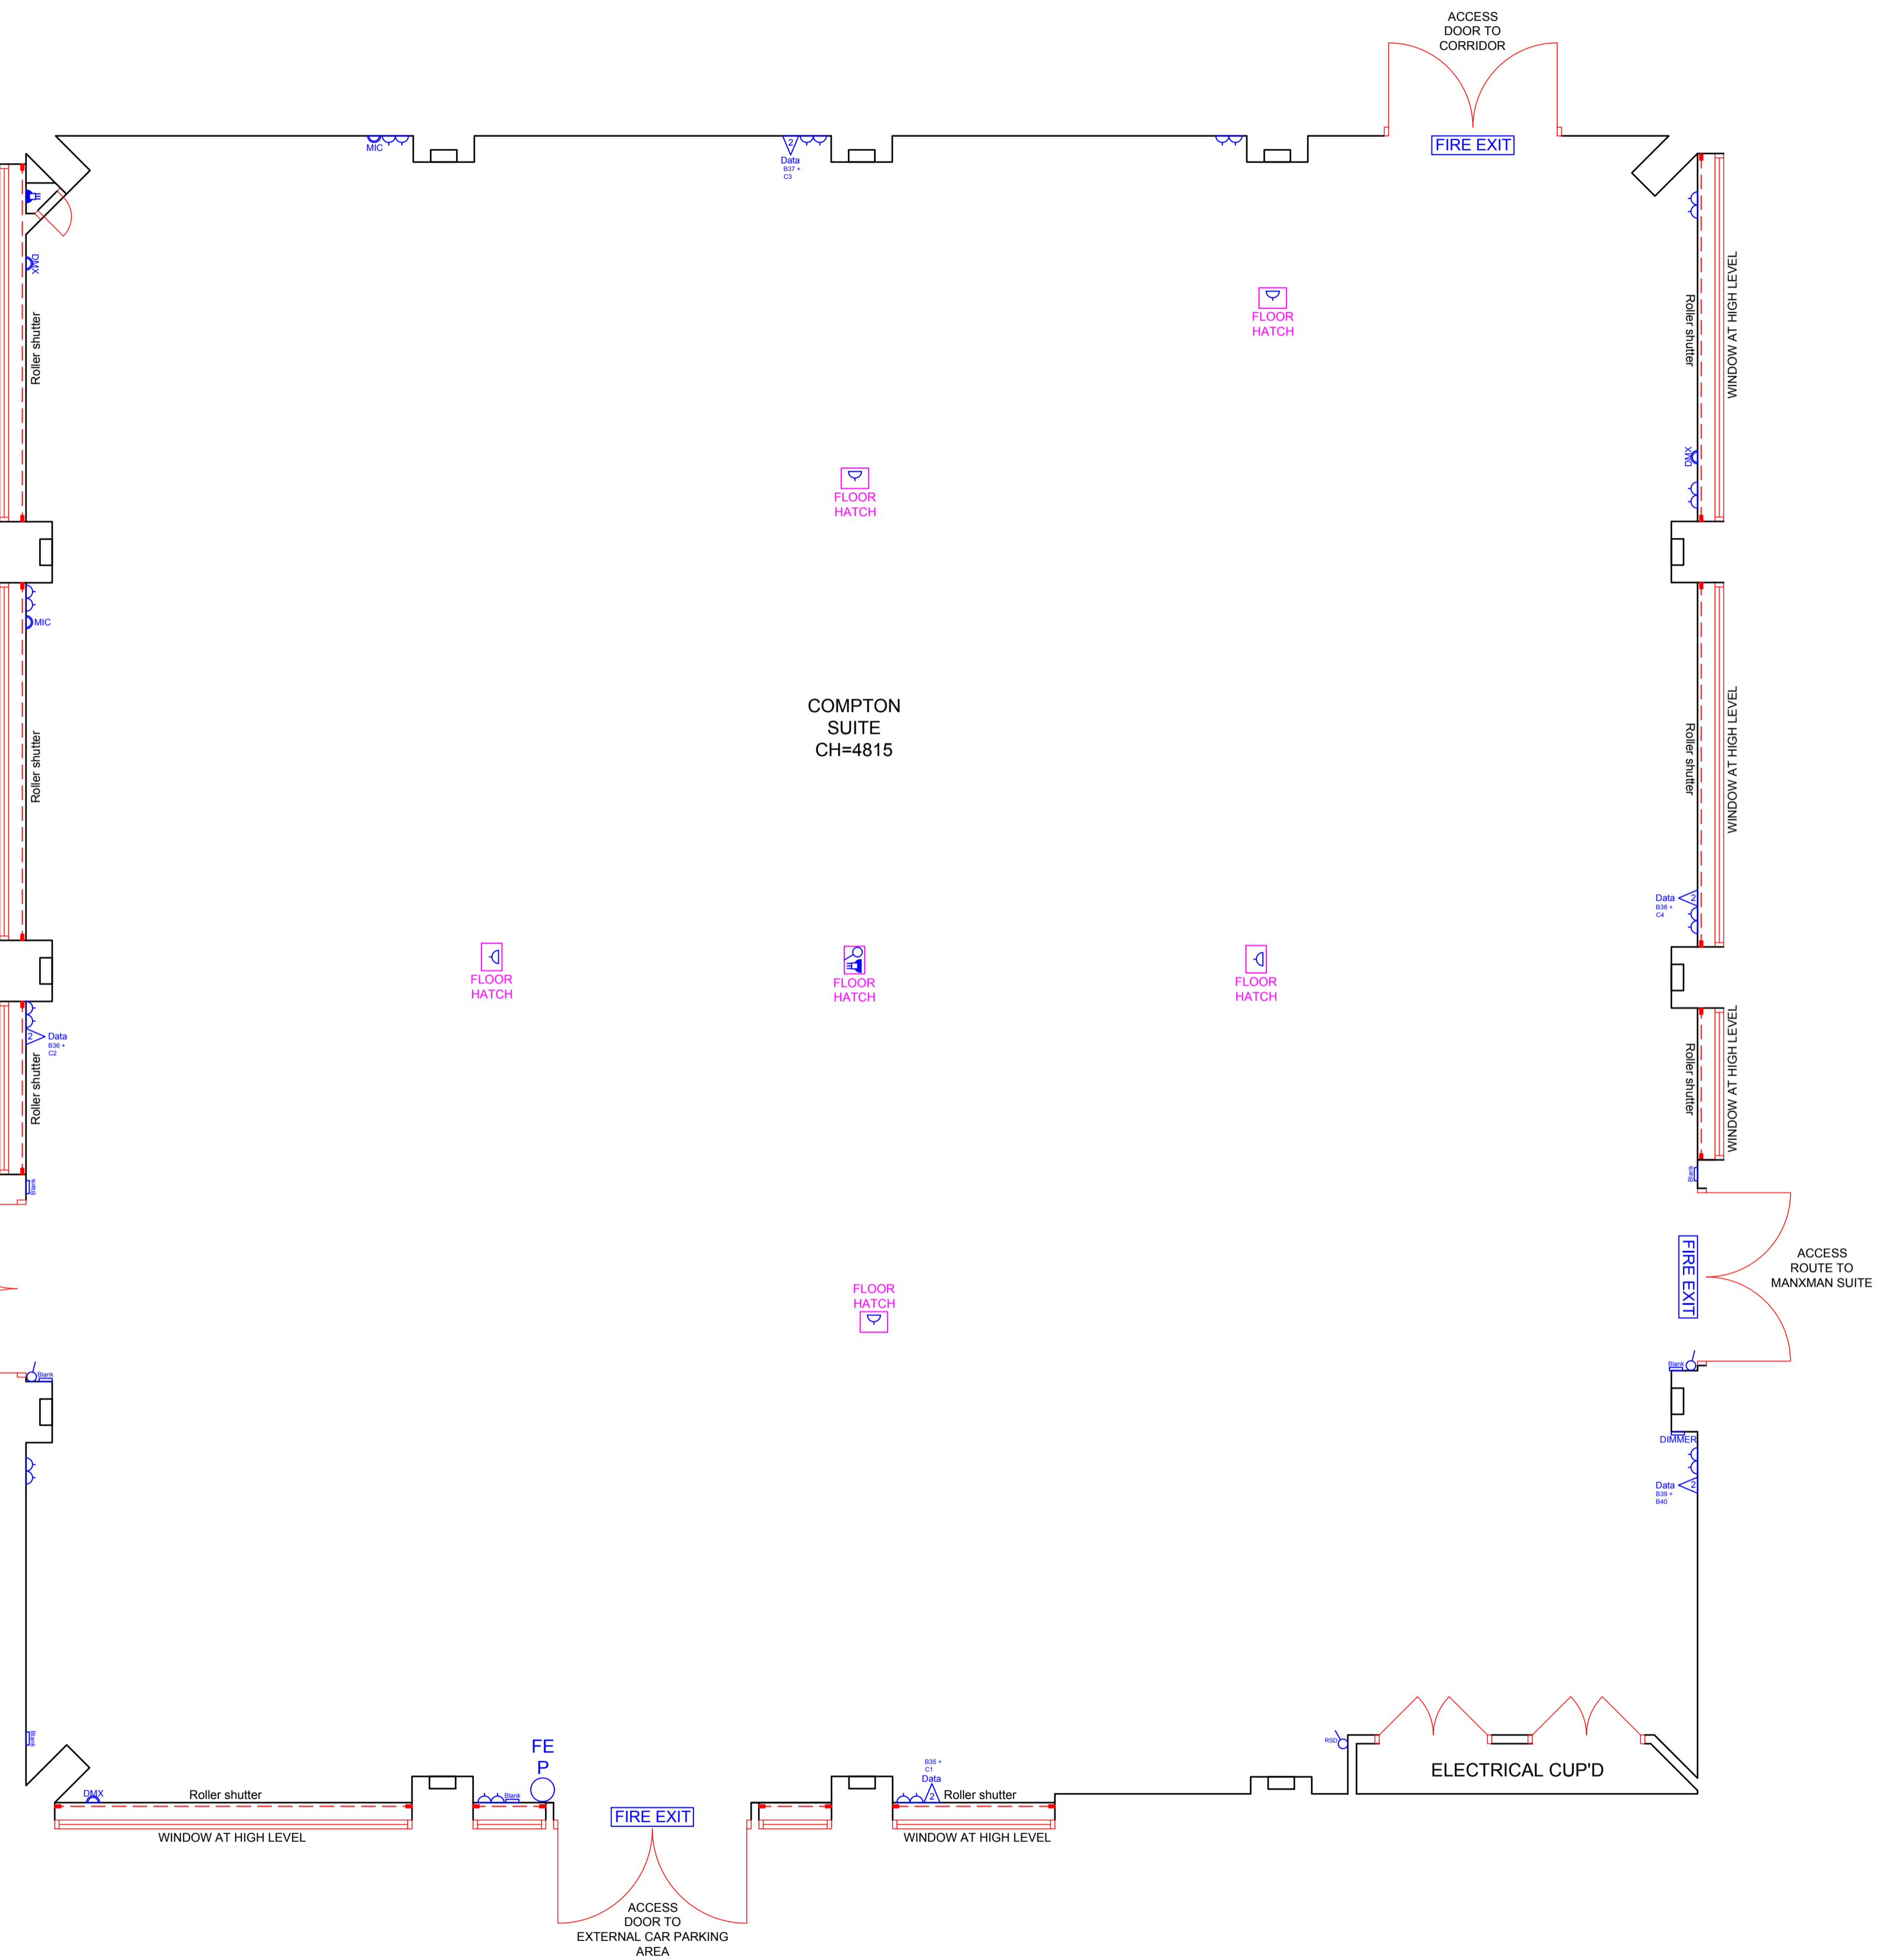

(COMPTON SUITE) Ground floor

REV.	DATE	BY	DESCRIPTION

CADS
Surveys
C A Design Services Limited
The Design Centre, Hewett Road, Gapton Hall,
Great Yarmouth, Norfolk NR31 0NN
Tel: 01493 440444 www.cadssurveys.co.uk
Registered in England No. 1595687

CLIENT: NATIONAL CONFERENCE CENTRE

SITE ADDRESS: COVENTRY ROAD,
BICKENHILL,
SOLIHULL,
B92 0EJ

TITLE: COMPTON SUITE
EXISTING FLOOR PLAN

DRAWN BY	DATE	SCALE	SHEET SIZE
LS	JUNE 2016	1/50@A1	A1
CHECKED BY	DATE	APPROVED BY	DATE
LS/IT	JUNE 2016	CADS	JUNE 2016
DRAWING No.	REVISION		
31799_COMPTON	0		