

Legends:


Gross Internal Areas
Manxman Suite
Total - 359m² (3864 ft²)

SYMBOLS LEGEND

	ROLLER SHUTTERS UP/DOWN SWITCH
	SINGLE LIGHT SWITCH
	DOUBLE LIGHT SWITCH
	DIMMER LIGHT SWITCH
	DIMMER CONTROL PANEL
	BLANK PLATE
	SINGLE SOCKET
	DOUBLE SOCKET
	WALL MOUNTED DMX SOCKET
	WALL MOUNTED MICROPHONE SOCKET
	3 PHASE ISOLATOR PLUG SOCKET
	5amp (x10pin) SOCKET
	SINGLE DATA SOCKET
	DOUBLE DATA SOCKET
	ROOM TEMPERATURE CONTROL/DISPLAY
	FIRE EXIT SIGN
	FIRE BREAK GLASS POINT
	FIRE EXTINGUISHER (WATER)
	FIRE EXTINGUISHER (CARBON DIOXIDE)
	FIRE EXTINGUISHER (FOAM)
	FIRE EXTINGUISHER (POWDER)

Level Data	Fence Types
Spot Levels	Barbed Wire
Tree Levels	Chain Barbed
	Concrete Post
	Chain Link
	Concrete Piling
	Iron Piling
	Post & Rail
	Post & Rail
	Post & Wire
	Post & Wire

Abbreviations	Maximum Internal Height
ACU	Air Conditioner Unit
BA	Banner
BB	Barbed/Chain
BO	Bobbed
BS	Bus Stop
BU	Bus
CATV	Cable TV Cover
CH	Ceiling Height
CHC	Ceiling Height Change
CHH	Clear Internal Height
CL	Cover Level
CPS	Concrete Paving Slabs
CSU	Cable Street Up
DR	Door Height
DRP	Door Type
DS	Down
EHL	Earth Rod
ER	Earth Rod
FLL	Finished Floor Level
FL	Floor Level
FR	Fire Hydrant
GS	Gully Cover
H	Height
IC	Inspection Chamber
LPH	Lamp Post
MW	Manhole
MSH	Maximum Internal Height
OH	Opening Height
PH	Post Box
PM	Paving Meter
PO	Post
RA	Rail
RE	Reinforcing Eye
RFV	Roof Floor Void
RS	Road Sign
RSW	Roadmeter Pipe
S	Sign
SC	Step Cock
SCM	Submerged Ceiling Height
SH	Sign Post
SHN	Shed
SHV	Shed Valve
SHW	Shed Wall
SHY	Shed Yards
TAC	Take Across Cover
TC	Telephone Cover
TB	Telephone Box
TL	Traffic Light
TR	Takeoff Point
UC	Underpass Cover
UNB	Underpass
UNB	Underpass Of Beam
UPL	Upland To Lift
VP	Vent Pipe
WCH	Window Over Height

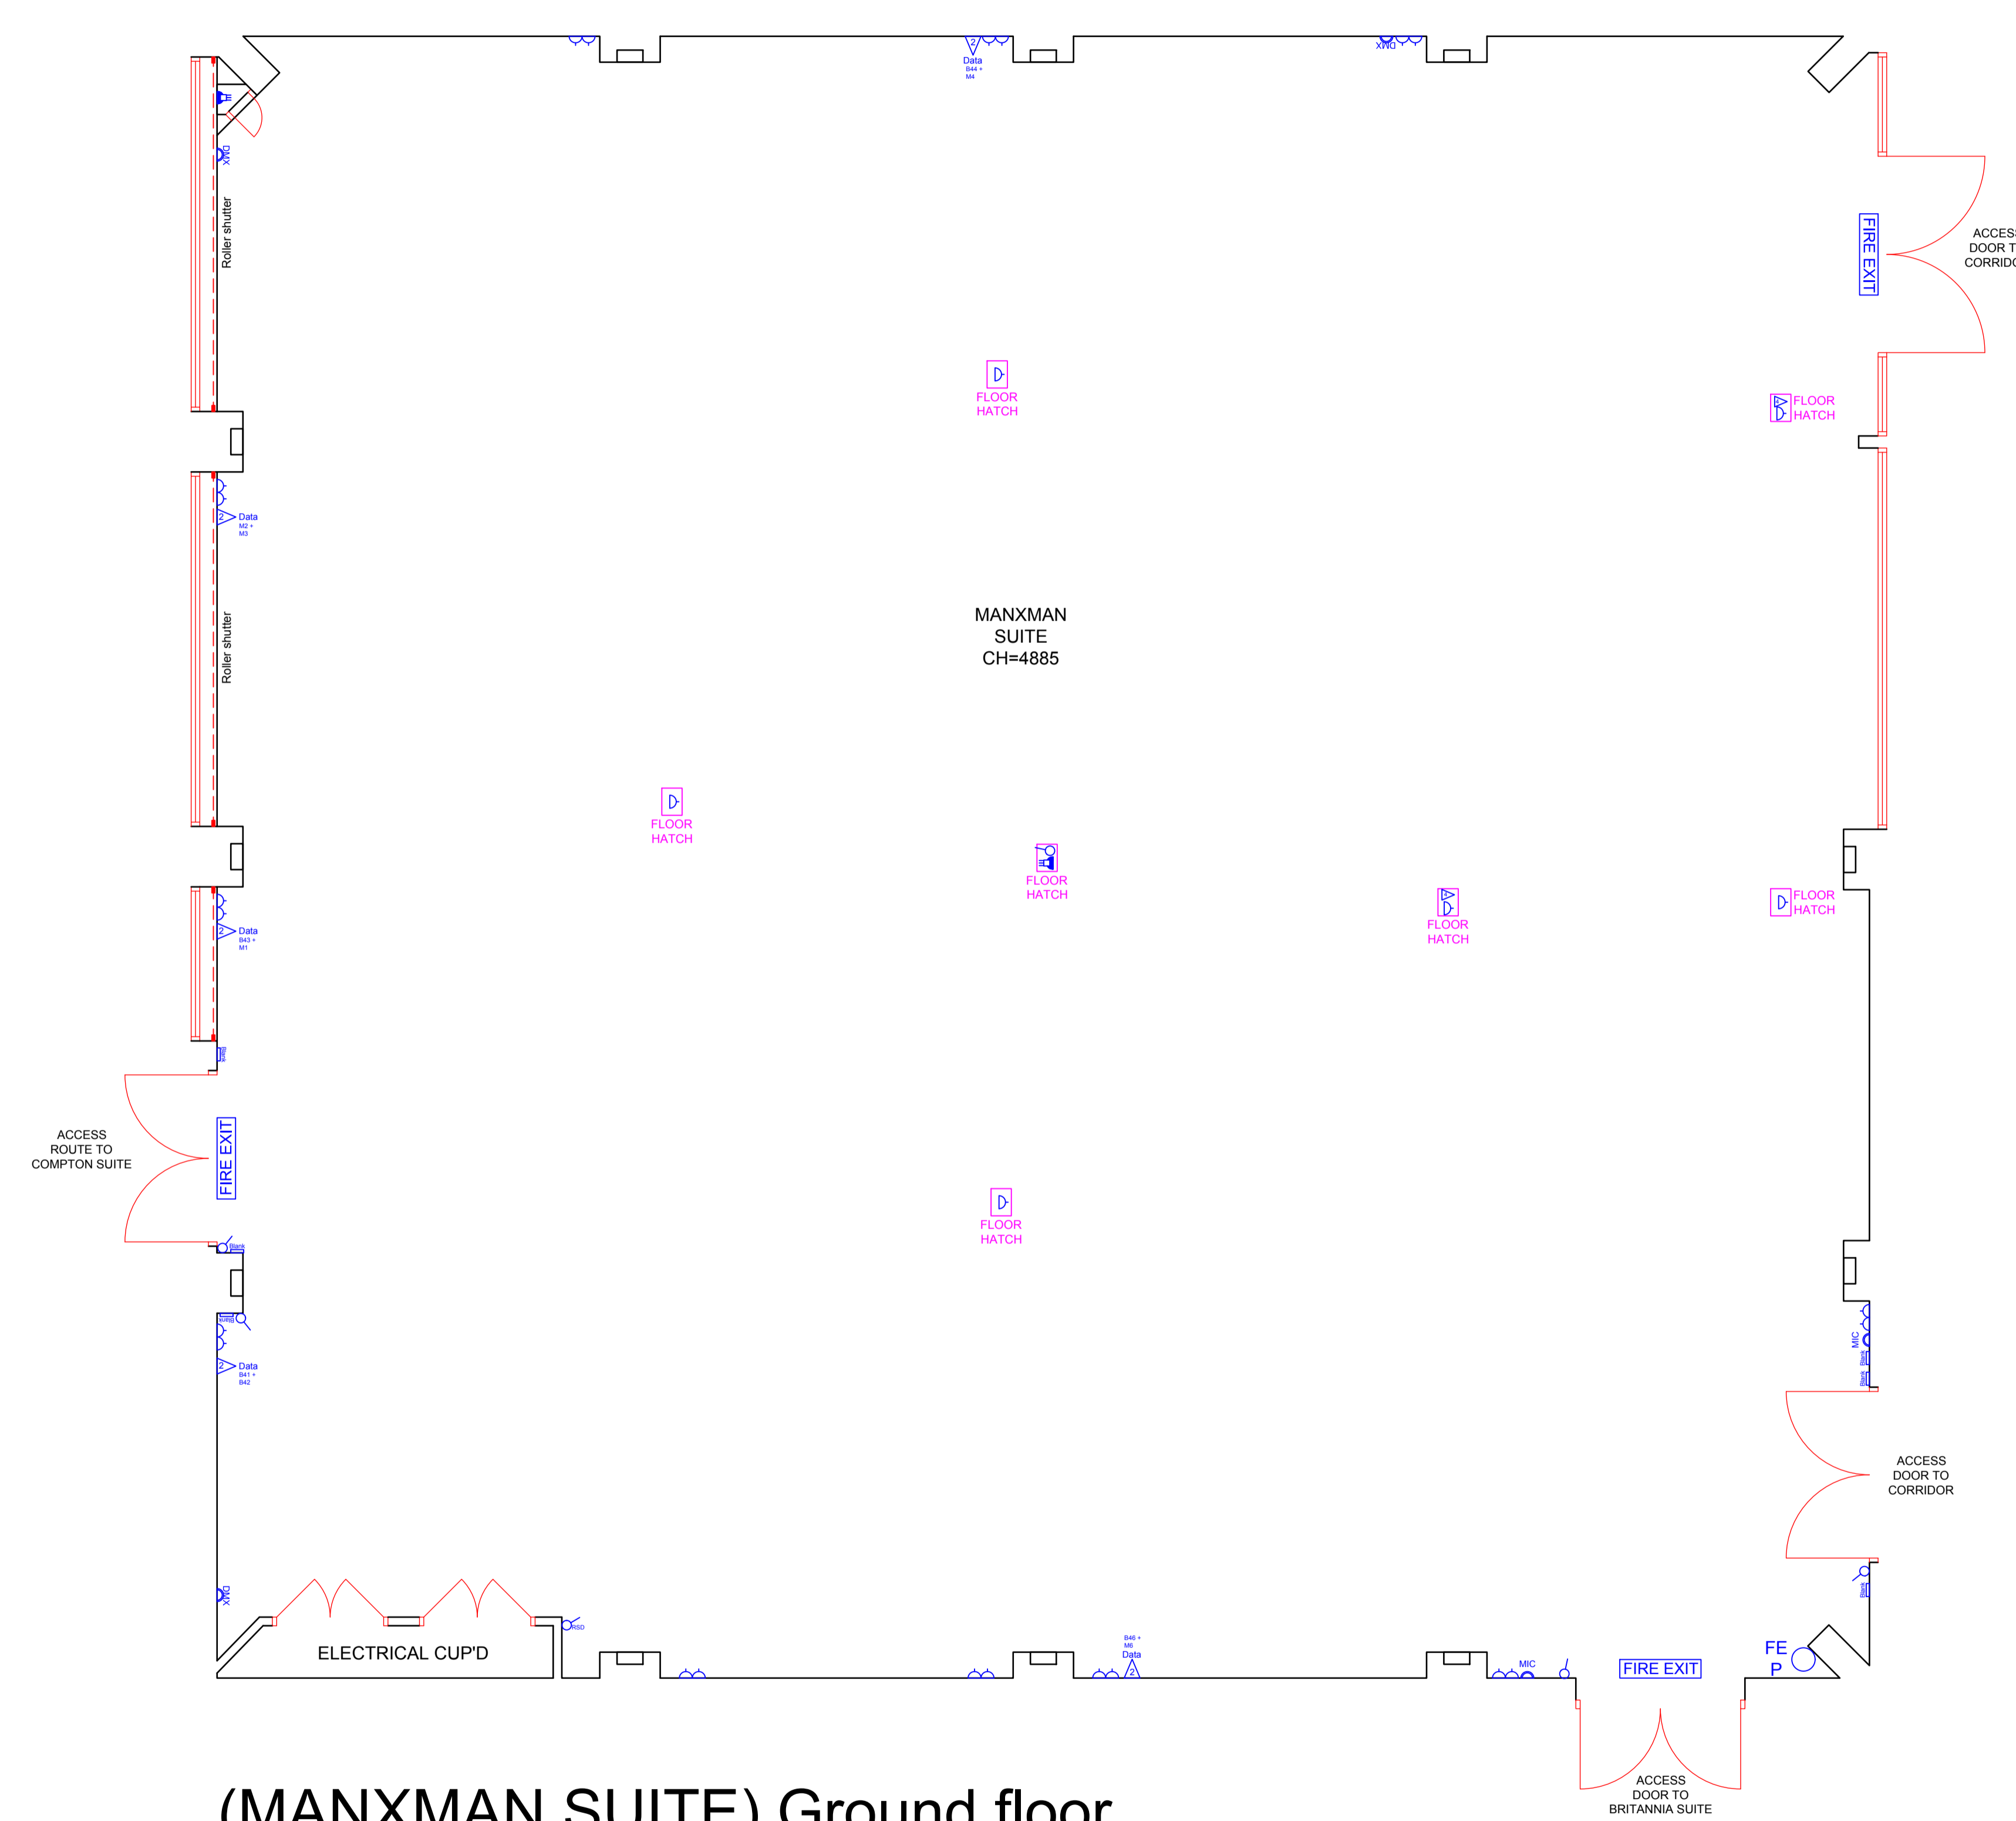

(MANXMAN SUITE) Ground floor

CADS
Surveys
 C A Design Services Limited
 The Design Centre, Hewett Road, Gapton Hall,
 Great Yarmouth, Norfolk NR31 0NW
 Tel: 01493 440444 www.cadesignservices.co.uk
 Registered in England No. 1595687

CLIENT		NATIONAL CONFERENCE CENTRE	
SITE ADDRESS		COVENTRY ROAD, BICKENHILL, SOLIHULL, B92 0EJ	
TITLE		MANXMAN SUITE EXISTING FLOOR PLAN	
DRAWN BY	DATE	SCALE	SHEET SIZE
LS	JUNE 2016	1/50@A1	A1
CHECKED BY	DATE	APPROVED BY	DATE
LS/IT	JUNE 2016	CADS	JUNE 2016
DRAWING No.	31799_MANXMAN		REVISION
			0