

Legends:


Gross Internal Areas
Manxman Suite
Total - 359m² (3864 ft²)

SYMBOLS LEGEND

| | |
|--|------------------------------------|
| | ROLLER SHUTTERS UP/DOWN SWITCH |
| | SINGLE LIGHT SWITCH |
| | DOUBLE LIGHT SWITCH |
| | DIMMER LIGHT SWITCH |
| | DIMMER CONTROL PANEL |
| | BLANK PLATE |
| | SINGLE SOCKET |
| | DOUBLE SOCKET |
| | WALL MOUNTED DMX SOCKET |
| | WALL MOUNTED MICROPHONE SOCKET |
| | 3 PHASE ISOLATOR PLUG SOCKET |
| | 5amp (x10pin) SOCKET |
| | SINGLE DATA SOCKET |
| | DOUBLE DATA SOCKET |
| | ROOM TEMPERATURE CONTROL/DISPLAY |
| | FIRE EXIT SIGN |
| | FIRE BREAK GLASS POINT |
| | FIRE EXTINGUISHER (WATER) |
| | FIRE EXTINGUISHER (CARBON DIOXIDE) |
| | FIRE EXTINGUISHER (FOAM) |
| | FIRE EXTINGUISHER (POWDER) |

| Level Data | | Fence Types | |
|-------------------------|--------------------|-------------|---------------|
| Spot Levels | + 00.75 | CB | Close Boarded |
| Tree Levels | | CL | Chain Link |
| Tree Area | Drawn To Scale On | CP | Chain Piling |
| The Survey | Descriptions Shown | IR | Iron Railing |
| Only Be Used As A Guide | | PP | Painted Poles |
| | | PR | Post & Rail |
| | | PTW | Post & Wire |
| Beach | 0m | | |
| Type | Height | | |
| UK | Unknown Tree Type | | |

| Abbreviations | | Fence Types | |
|---------------|-----------------------|-------------|--------------------------|
| ACU | Air Conditioner Unit | MSH | Maximum Internal Height |
| BA | Banner | OH | Opening Height |
| BB | Balustrade | PS | Post & Spigot |
| BD | Ballast | PM | Perimeter Meter |
| BS | Bus Stop | PD | Post |
| BU | Bush | RA | Rail |
| CATV | Cable TV Cover | RE | Retaining Edge |
| CH | Ceiling Height | RFV | Raised Floor Void |
| CHC | Ceiling Height Change | RS | Road Sign |
| CHH | Clear Internal Height | RSW | Rainwater Pipe |
| CL | Cover Level | S | Sign |
| CPS | Concrete Paving Slabs | SC | Step Curb |
| CSU | Cable Street Up | SCM | Submerged Ceiling Height |
| DF | Door Height | SI | Sign Post |
| DFP | Door Type | STN | Station |
| DS | Down | SV | Sign Vane |
| EH | Earth Rod | SWP | Spot Weld Pipe |
| EH | Earth Height | TAC | Tank Access Cover |
| ETD | Earth Duct | TC | Telephone Cover |
| FLL | Finished Floor Level | TB | Telephone Box |
| FL | Floor Level | TL | Traffic Light |
| FR | Fire Hydrant | TR | Telephone Pole |
| GD | Gully Cover | UC | Underpass Cover |
| H | Height | UNB | Underpass |
| IC | Inspection Chamber | UNBSP | Underpass Of Span |
| LPI | Lamp Post | UPL | Uplift To Lift |
| MAN | Manhole | VP | Vent Pipe |
| | | WOH | Window Over Height |

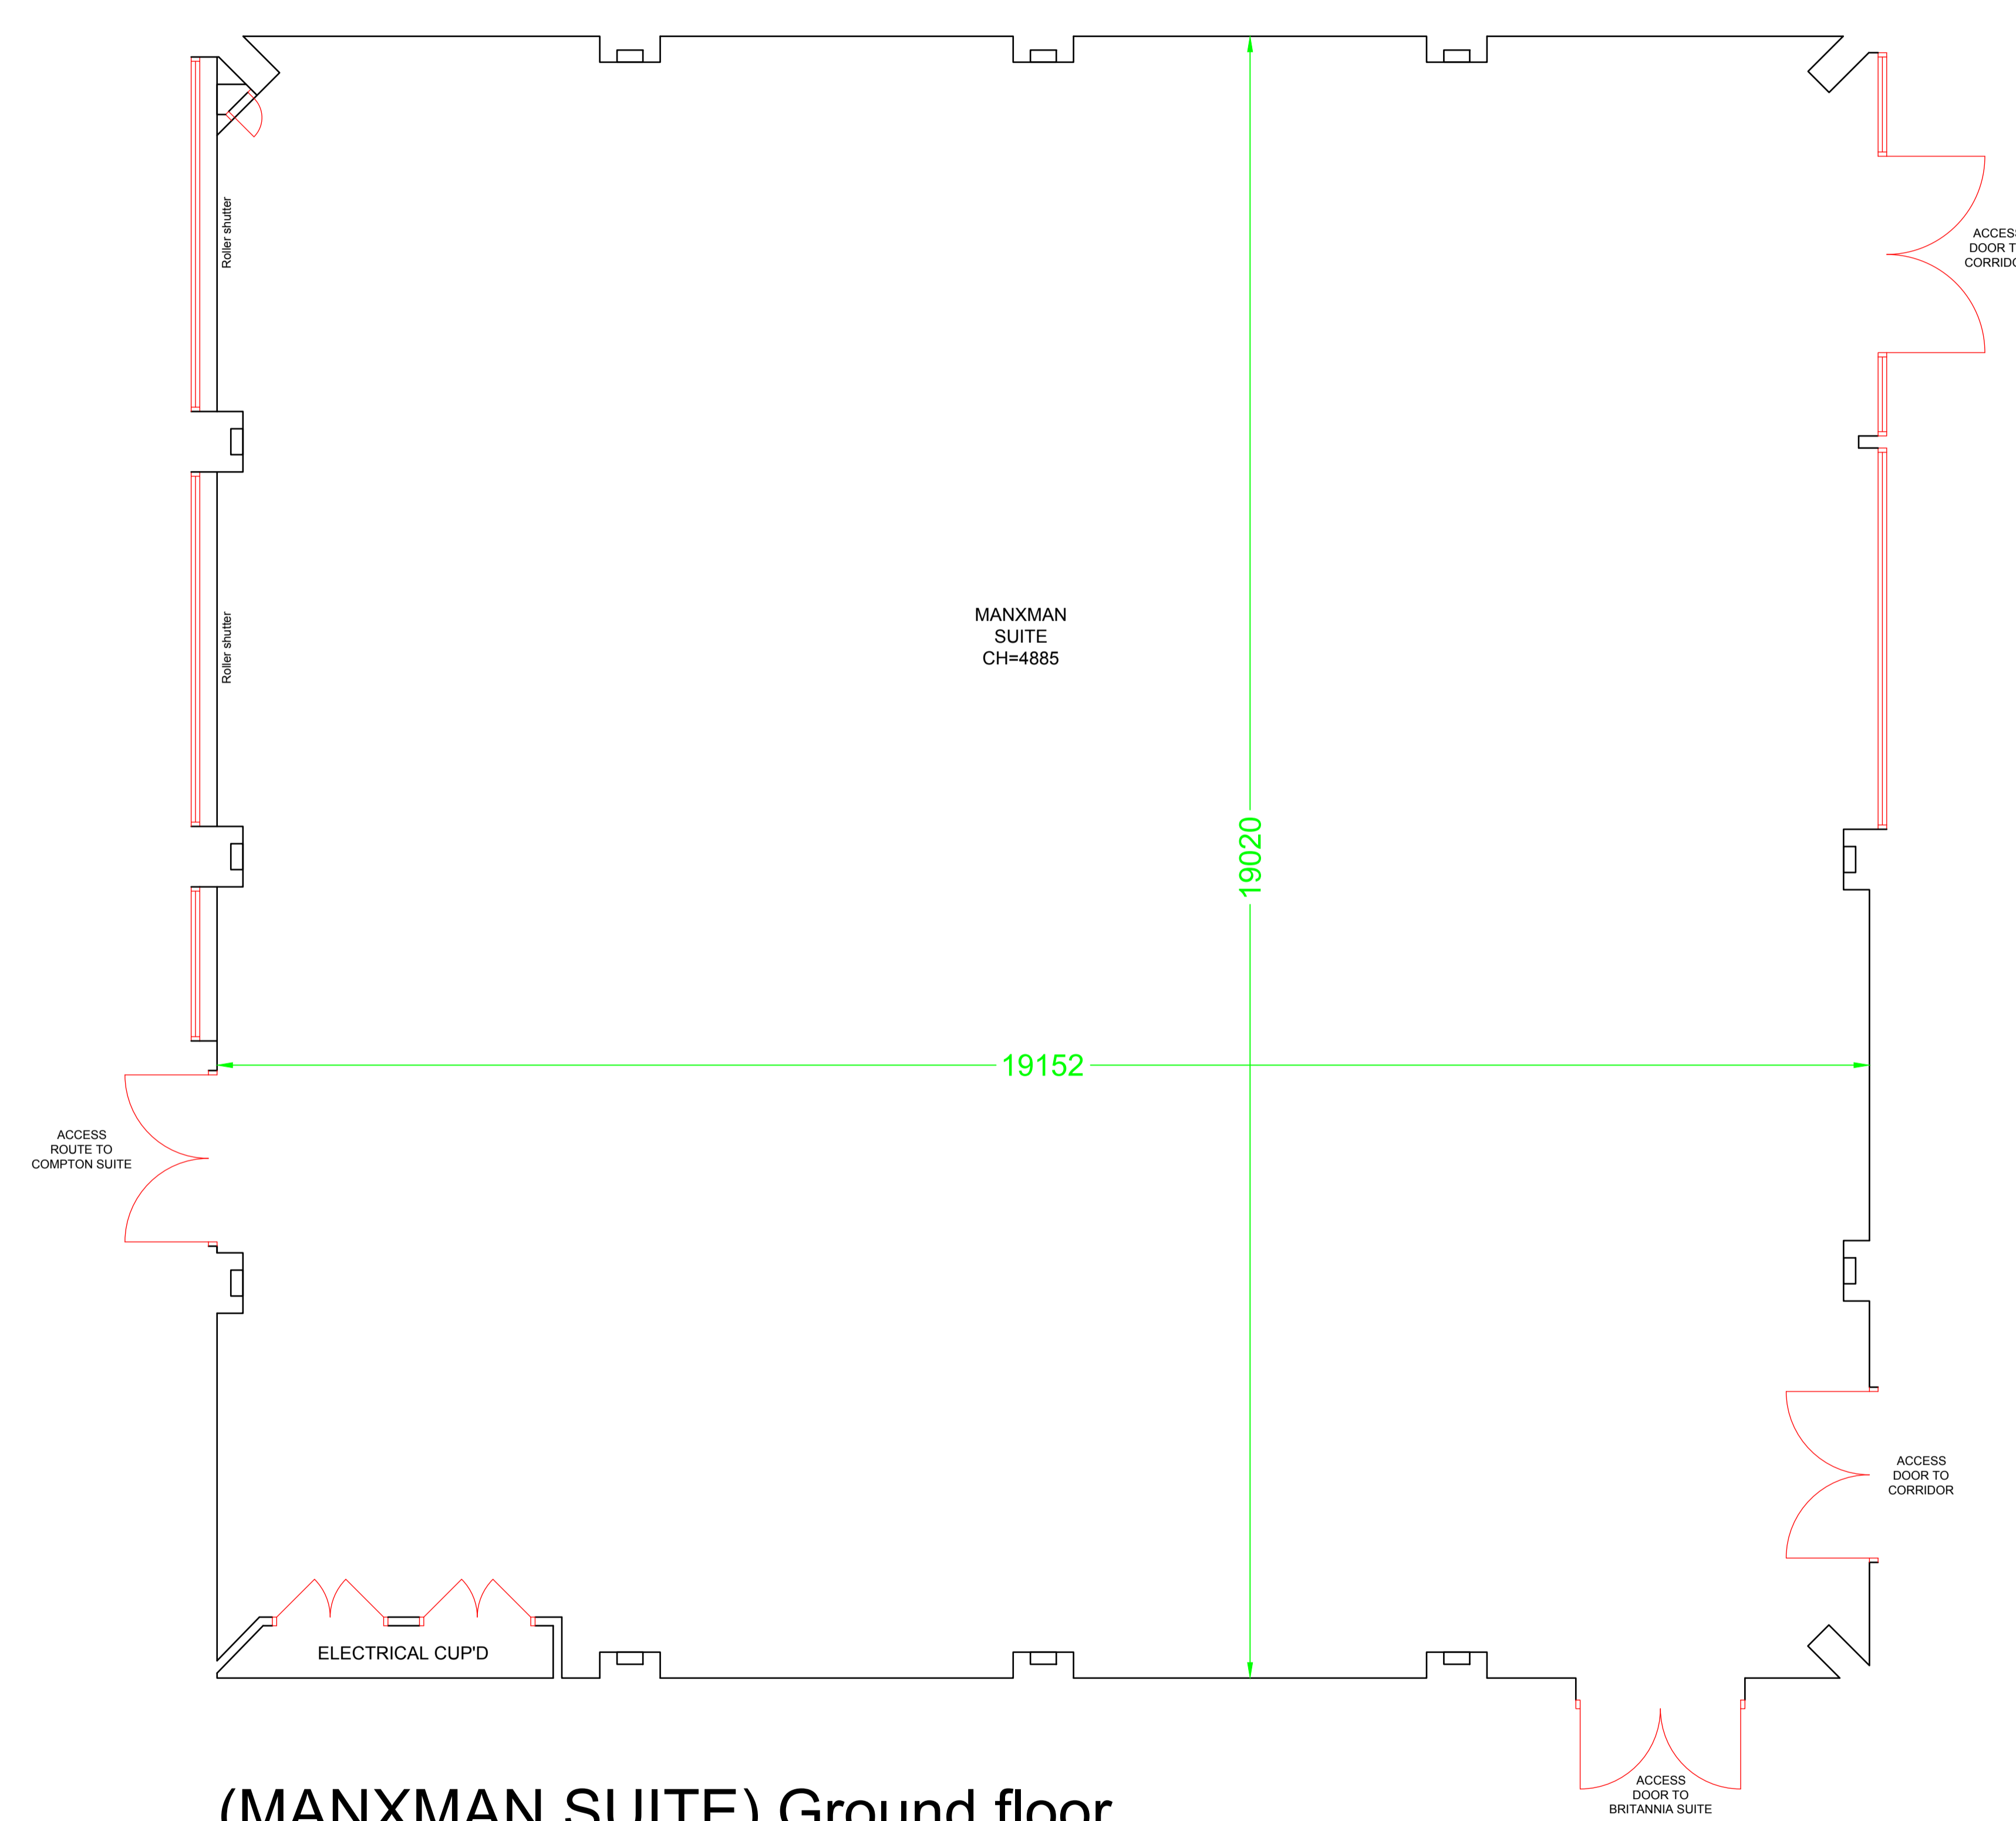

(MANXMAN SUITE) Ground floor

CADS
Surveys
 C A Design Services Limited
 The Design Centre, Hewett Road, Gapton Hall,
 Great Yarmouth, Norfolk NR31 0NW
 Tel: 01493 440444 www.cadesignservices.co.uk
 Registered in England No. 1595687

CLIENT: NATIONAL CONFERENCE CENTRE
 SITE ADDRESS: COVENTRY ROAD, BICKENHILL, SOLIHULL, B92 0EJ
 TITLE: MANXMAN SUITE EXISTING FLOOR PLAN

| REV. | DATE | BY | DESCRIPTION |
|------|------|----|-------------|
| | | | |
| | | | |
| | | | |

| DRAWN BY | DATE | SCALE | SHEET SIZE |
|---------------|-----------|-------------|------------|
| LS | JUNE 2016 | 1/50@A1 | A1 |
| CHECKED BY | DATE | APPROVED BY | DATE |
| LS/IT | JUNE 2016 | CADS | JUNE 2016 |
| DRAWING No. | REVISION | | |
| 31799_MANXMAN | 0 | | |