

Legends:

Gross Internal Areas

Premier Suite
Total - 398m² (4284 ft²)


SYMBOLS LEGEND

	ROLLER SHUTTERS UP/DOWN SWITCH
	SINGLE LIGHT SWITCH
	DOUBLE LIGHT SWITCH
	DIMMER LIGHT SWITCH
	DIMMER CONTROL PANEL
	BLANK PLATE
	SINGLE SOCKET
	DOUBLE SOCKET
	WALL MOUNTED DMX SOCKET
	WALL MOUNTED MICROPHONE SOCKET
	3 PHASE ISOLATOR PLUG SOCKET
	5amp (x10pin) SOCKET
	SINGLE DATA SOCKET
	DOUBLE DATA SOCKET
	ROOM TEMPERATURE CONTROL/DISPLAY
	FIRE EXIT SIGN
	FIRE BREAK GLASS POINT
	FIRE EXTINGUISHER (WATER)
	FIRE EXTINGUISHER (CARBON DIOXIDE)
	FIRE EXTINGUISHER (FOAM)
	FIRE EXTINGUISHER (POWDER)

Level Data	
Spot Levels	+ 100.75
W	Worked
T	Tree
B	Boundary
C	Contour
D	Drain
F	Finish
H	Height
I	Internal
O	Original
P	Proposed
R	Road
S	Spot
U	Unknown

Fence Types	
Spot Levels	+ 100.75
CB	Close Boarded
CH	Chain Link
CL	Close Clipped
CP	Close Panel
CR	Close Rail
CS	Close Slatted
CT	Close Timber
CU	Close Unclipped
CV	Close Vertical
CA	Close Aluminium
CB	Close Boarded
CH	Chain Link
CL	Close Clipped
CP	Close Panel
CR	Close Rail
CS	Close Slatted
CT	Close Timber
CU	Close Unclipped
CV	Close Vertical
CA	Close Aluminium

Abbreviations	
ACU	Air Conditioning Unit
BA	Banner
BB	Balustrade
BD	Ballast
BS	Bus Stop
BU	Bus
CA	Car
CACTV	Cable TV Camera
CH	Ceiling Height
CHC	Ceiling Height Change
CHH	Clear Internal Height
CL	Cover Level
CPS	Concrete Paving Slabs
CSU	Concrete Slab Up
DF	Door Frame
DFH	Door Height
DFW	Door Width
EH	Earth Height
ER	Earth Road
FD	Flashed Detail
FFL	Finished Floor Level
FL	Floor Level
FS	Fire Stairs
GS	Gully Grate
H	Height
IC	Insulation Chamber
LPH	Lamp Post
M	Manhole
MH	Maximum Internal Height
OH	Opening Height
PH	Post Hole
PM	Perimeter Meter
PD	Post
RA	Rail
RE	Retaining Edge
RFV	Raised Floor Void
RS	Road Sign
RWP	Rainwater Pipe
S	Spot
SC	Step Curb
SCM	Submerged Ceiling Height
SH	Shelf
SHV	Shelf Void
SHW	Shelf Width
TAC	Task Access Cover
TC	Telephone Cover
TR	Telephone Box
TL	Traffic Light
TR	Telephone
TRP	Telephone Pole
UC	Underground
UNB	Underneath Of Beam
UNBHM	Underneath Of Beam
UPL	Underneath Of Light
VP	Vent Pipe
WCH	Window Cover Height

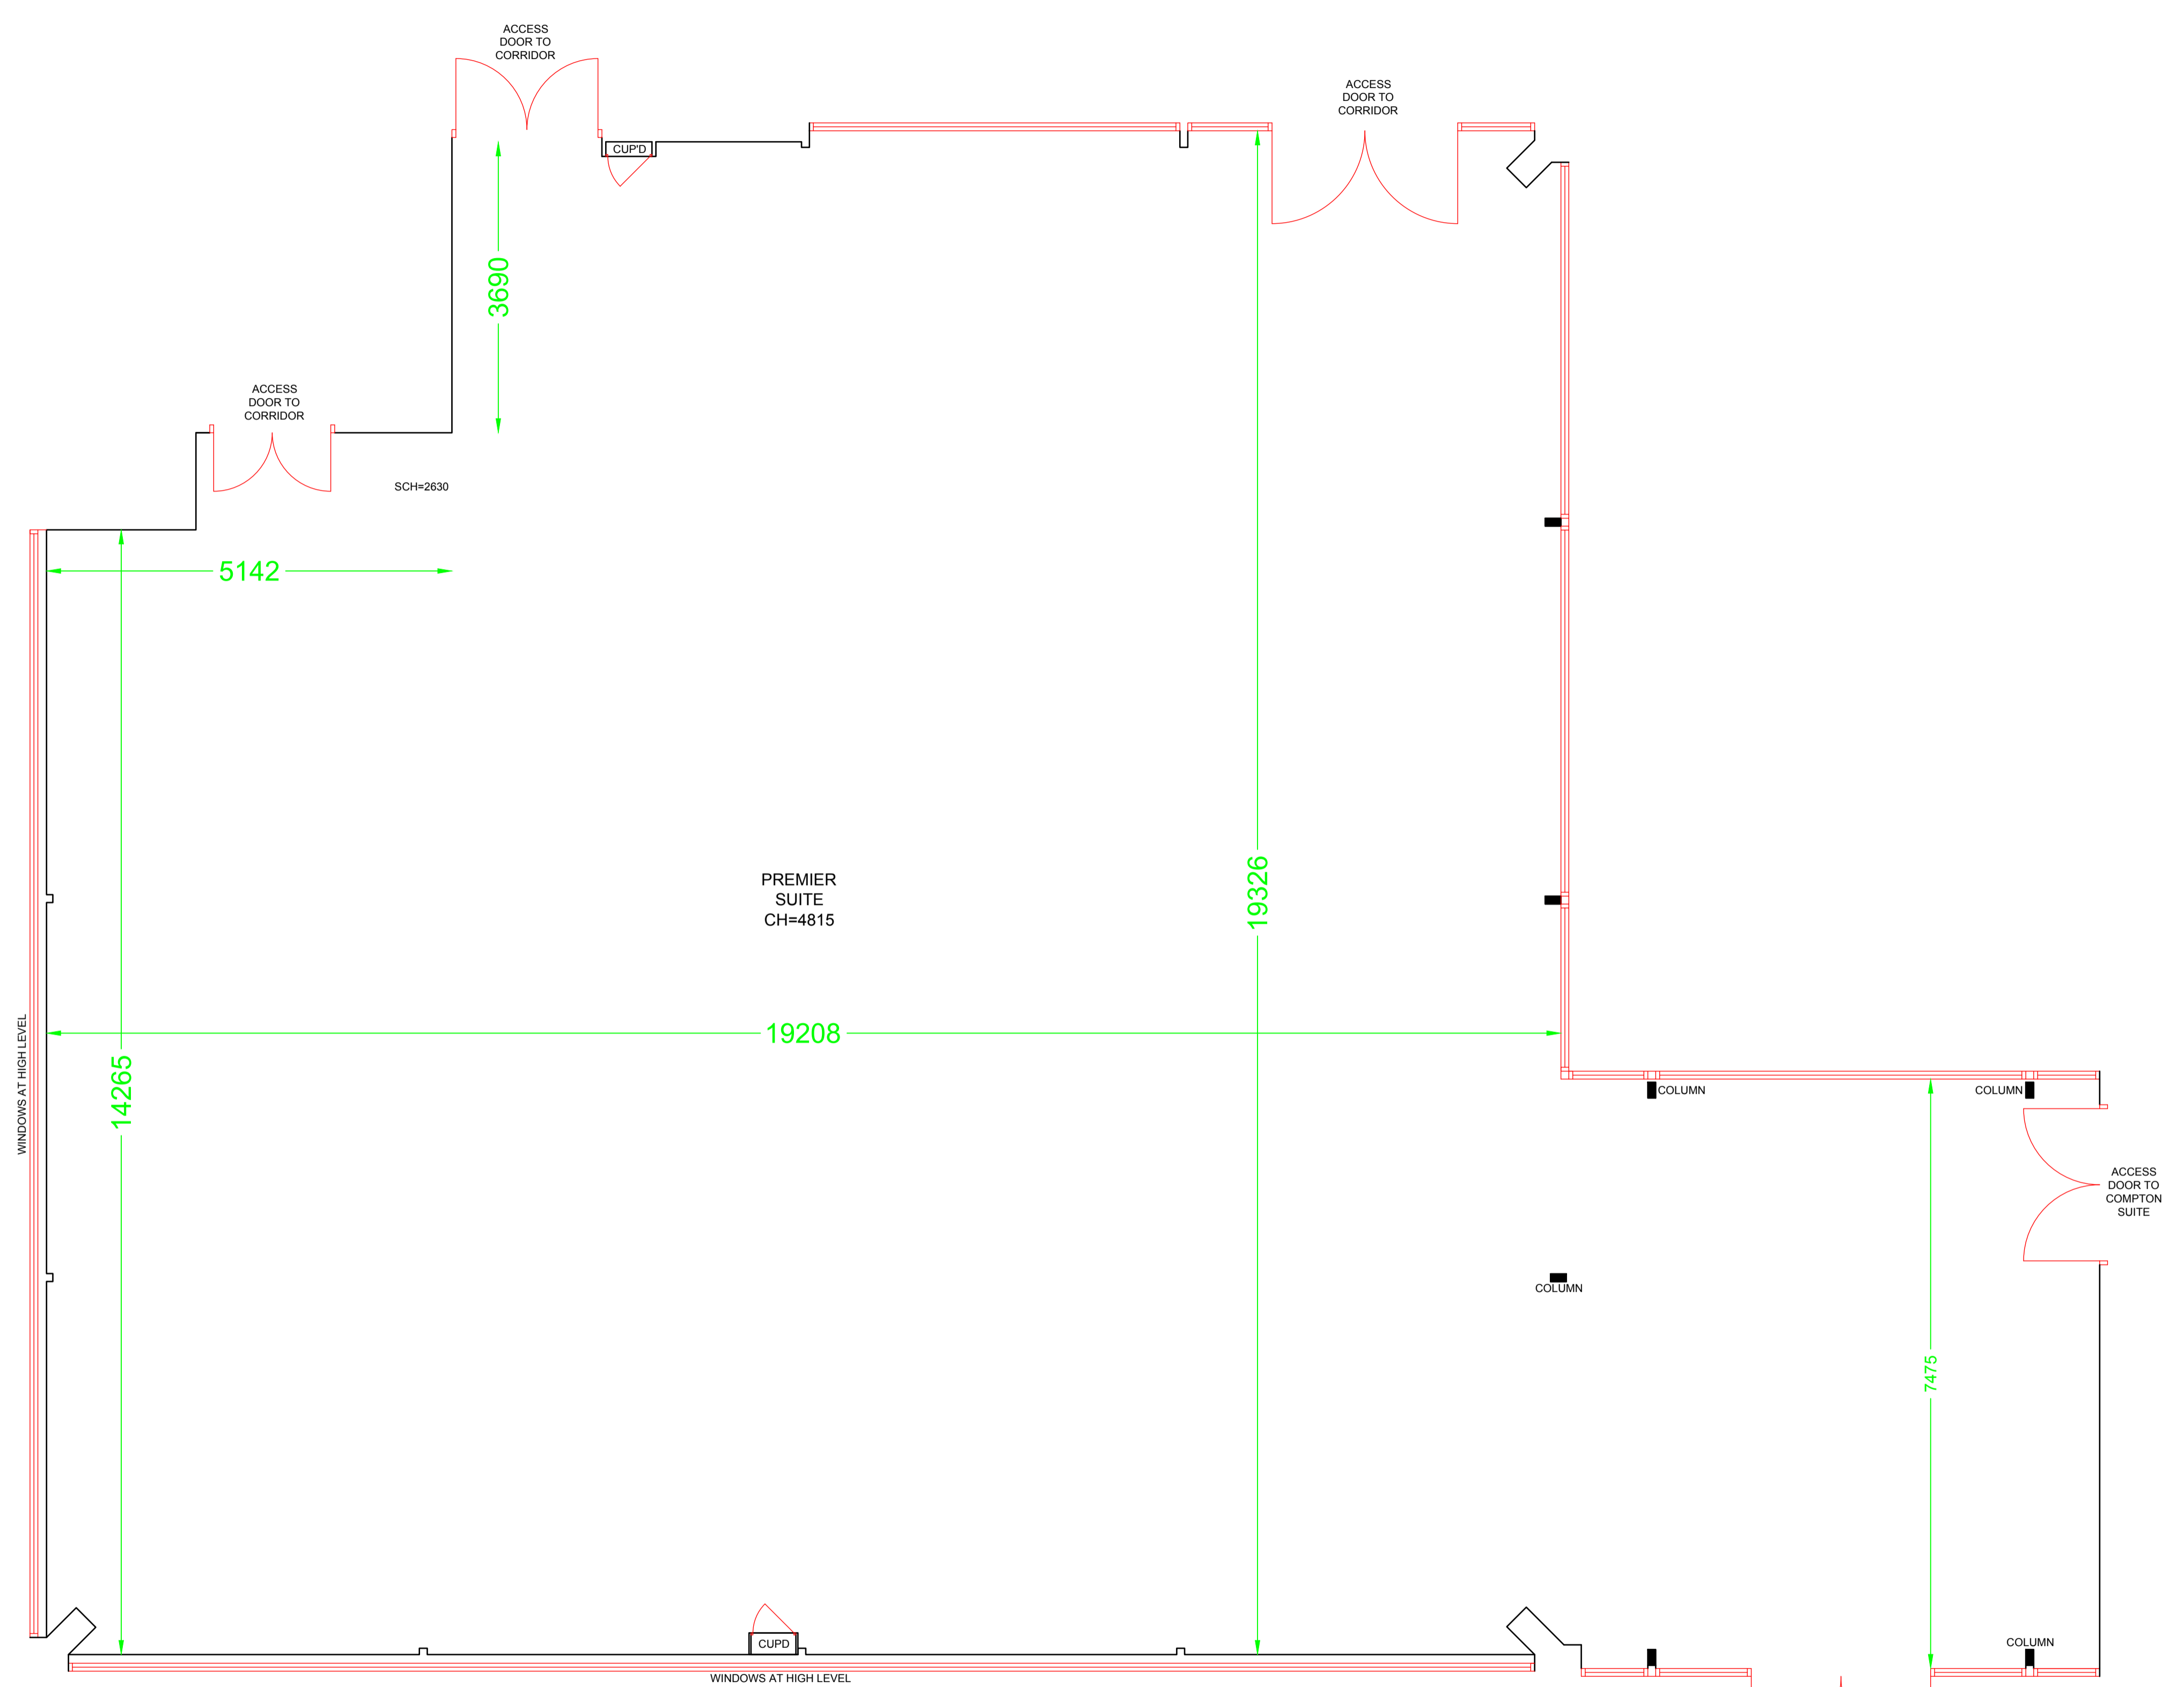

(PREMIER SUITE) Ground floor

REV.	DATE	BY	DESCRIPTION

CADS
Surveys
C A Design Services Limited
The Design Centre, Hewett Road, Gapton Hall,
Great Yarmouth, Norfolk NR31 0NW
Tel: 01493 440444 www.cadsdesignservices.co.uk
Registered in England No. 1595687

CLIENT: NATIONAL CONFERENCE CENTRE
SITE ADDRESS: COVENTRY ROAD, BICKENHILL, SOLIHULL, B92 0EJ

TITLE: PREMIER SUITE EXISTING FLOOR PLAN

DRAWN BY	DATE	SCALE	SHEET SIZE
LS	JUNE 2016	1/50@A1	A1
CHECKED BY	DATE	APPROVED BY	DATE
LS/IT	JUNE 2016	CADS	JUNE 2016

DRAWING No. 31799 PREMIER REVISION 0