

This drawing should only be used for its original purpose. CADS accepts no responsibility for the drawing if required by any other party than the original client. Neither is responsibility accepted if the drawing or any part of it is reproduced or transmitted by electronic or other means without the prior written consent of CADS. While every effort has been made to identify and specify all items of work on this drawing, it is not intended to be a complete specification before any final decisions are made. Damage information has been visually inspected and measured from the surface, therefore should be treated as approximate only.



Please note: all dimensions to be checked on site by contractors prior to commencement of work.

Legends:

Gross Internal Areas


Waterloo Suite
Total - 249m² (2680 ft²)

SYMBOLS LEGEND

☒	ROLLER SHUTTERS UP/DOWN SWITCH
☒	SINGLE LIGHT SWITCH
☒ 2	DOUBLE LIGHT SWITCH
☒	DIMMER LIGHT SWITCH
☒	DIMMER CONTROL PANEL
☒	BLANK PLATE
☒	SINGLE SOCKET
☒	DOUBLE SOCKET
☒	WALL MOUNTED DMX SOCKET
☒	WALL MOUNTED MICROPHONE SOCKET
☒	3 PHASE ISOLATOR PLUG SOCKET
☒	5amp (x10pin) SOCKET
☒	SINGLE DATA SOCKET
☒	DOUBLE DATA SOCKET
☒	ROOM TEMPERATURE CONTROL/DISPLAY
☒	FIRE EXIT SIGN
☒	FIRE BREAK GLASS POINT
☒	FIRE EXTINGUISHER (WATER)
☒	FIRE EXTINGUISHER (CARBON DIOXIDE)
☒	FIRE EXTINGUISHER (FOAM)
☒	FIRE EXTINGUISHER (POWDER)

Spot Levels	Banded Sites	Fence Types	Class Banded
CS	Commercial Prem	CL	Chain Link
CS	Commercial Prem	CS	Chain Link
CS	Commercial Prem	CS	Chain Link
Abbreviations	Maximum Internal Height
ACU	Air Conditioning Unit
AS	Ambient
BS	Battery
BO	Bolton
BS	Bolton
BU	Bus
CACTV	Cable TV
CH	Chandelier
CHC	Cable TV Cable
CHI	Clear Internal Height
CL	Cover Level
CPS	Concrete Paving Slabs
CSSU	Cable Street Sign
DI	Door Height
DPI	Door Type
DS	Down Pipe
EA	Earth Rod
EAH	Earth Height
ER	Earth Rod
FD	Fire Door
FFL	Finished Floor Level
FL	Floor Level
FS	Fire Hydrant
GS	Gully Cover
H	Height
IC	Inspection Chamber
LPH	Lamp Post
MAP	Manhole

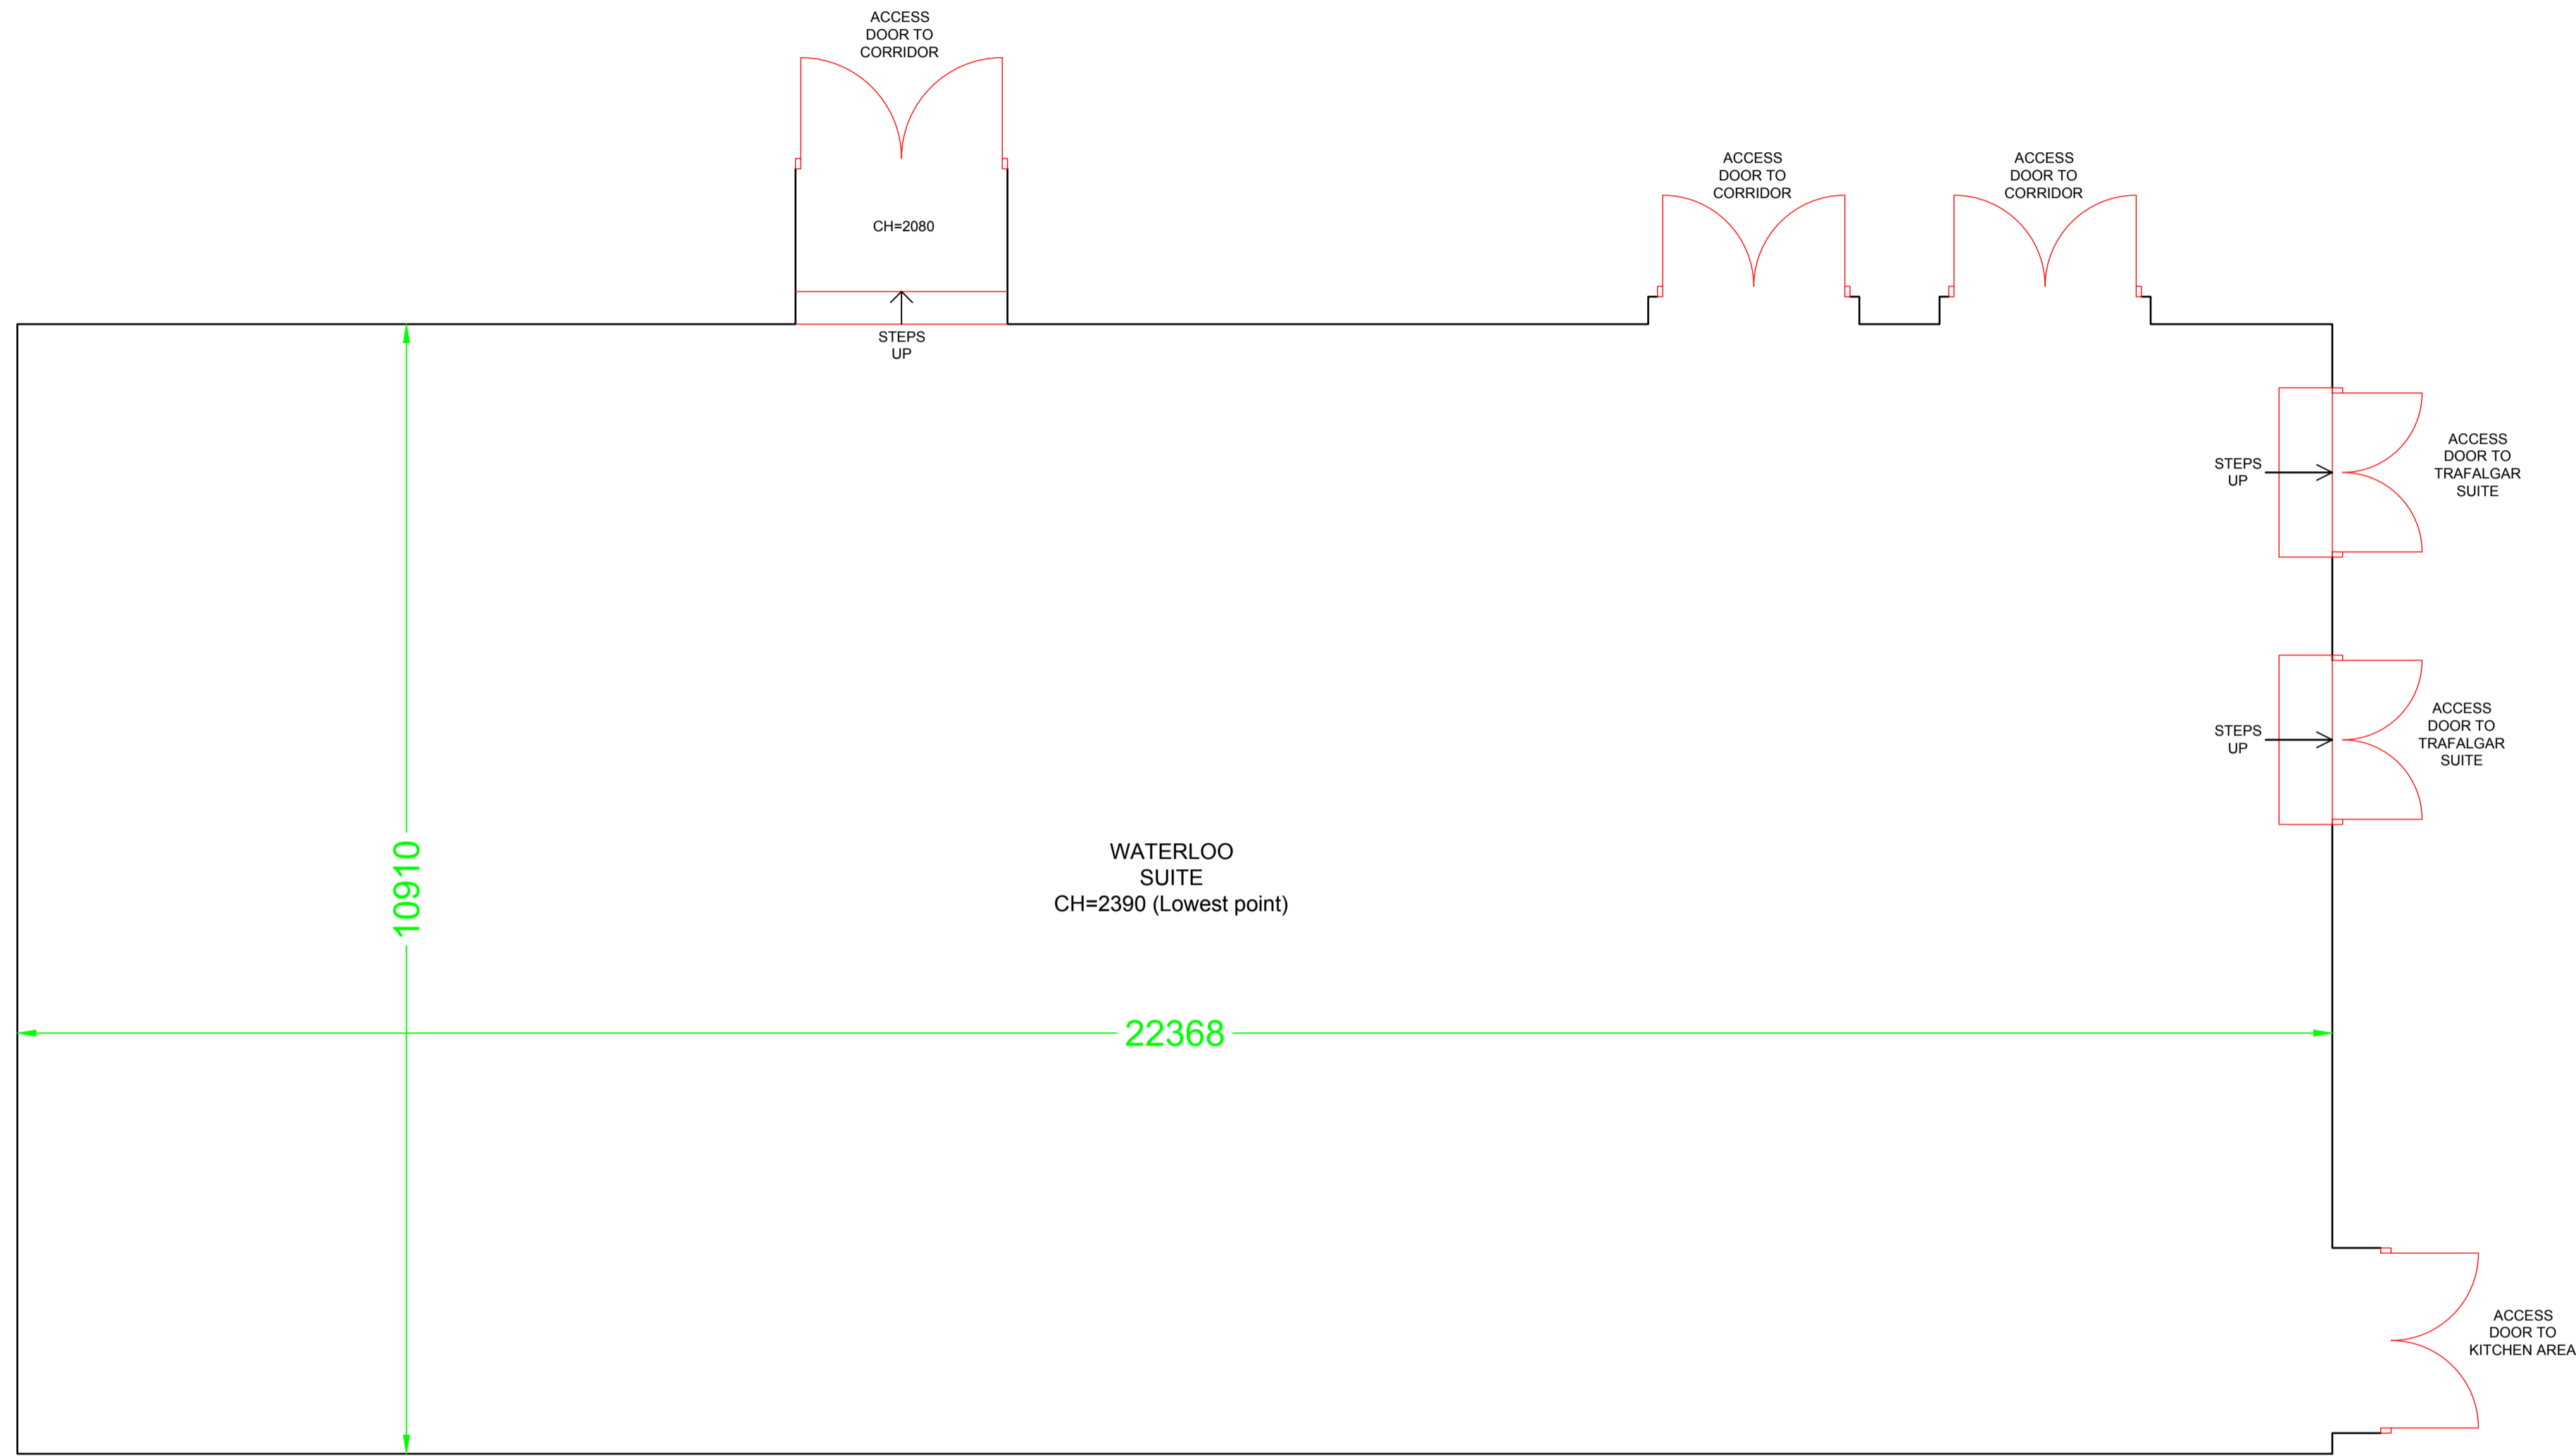

(WATERLOO SUITE) Level -2

REV.	DATE	BY	DESCRIPTION
------	------	----	-------------

CADS Surveys
C A Design Services Limited
The Design Centre, Hewett Road, Gipton Hall,
Great Yarmouth, Norfolk NR31 0NW
Tel: 01493 440444 www.cadsdesignservices.co.uk
Registered in England No. 1595687

CLIENT
NATIONAL CONFERENCE CENTRE

SITE ADDRESS
COVENTRY ROAD,
BICKENHILL,
SOLIHULL,
B92 0EJ

TITLE
WATERLOO SUITE
EXISTING FLOOR PLAN

DRAWN BY	DATE	SCALE	SHEET SIZE
LS	JUNE 2016	1/50@A1	A1

CHECKED BY	DATE	APPROVED BY	DATE
LS/IT	JUNE 2016	CADS	JUNE 2016

DRAWING No.	REVISION
31799_WATERLOO	0